


# Emergency Management Leaders Conference

## May 29-30, 2019

### Arizona Grand Resort and Spa - Grand Ballroom - ---- Phoenix, AZ

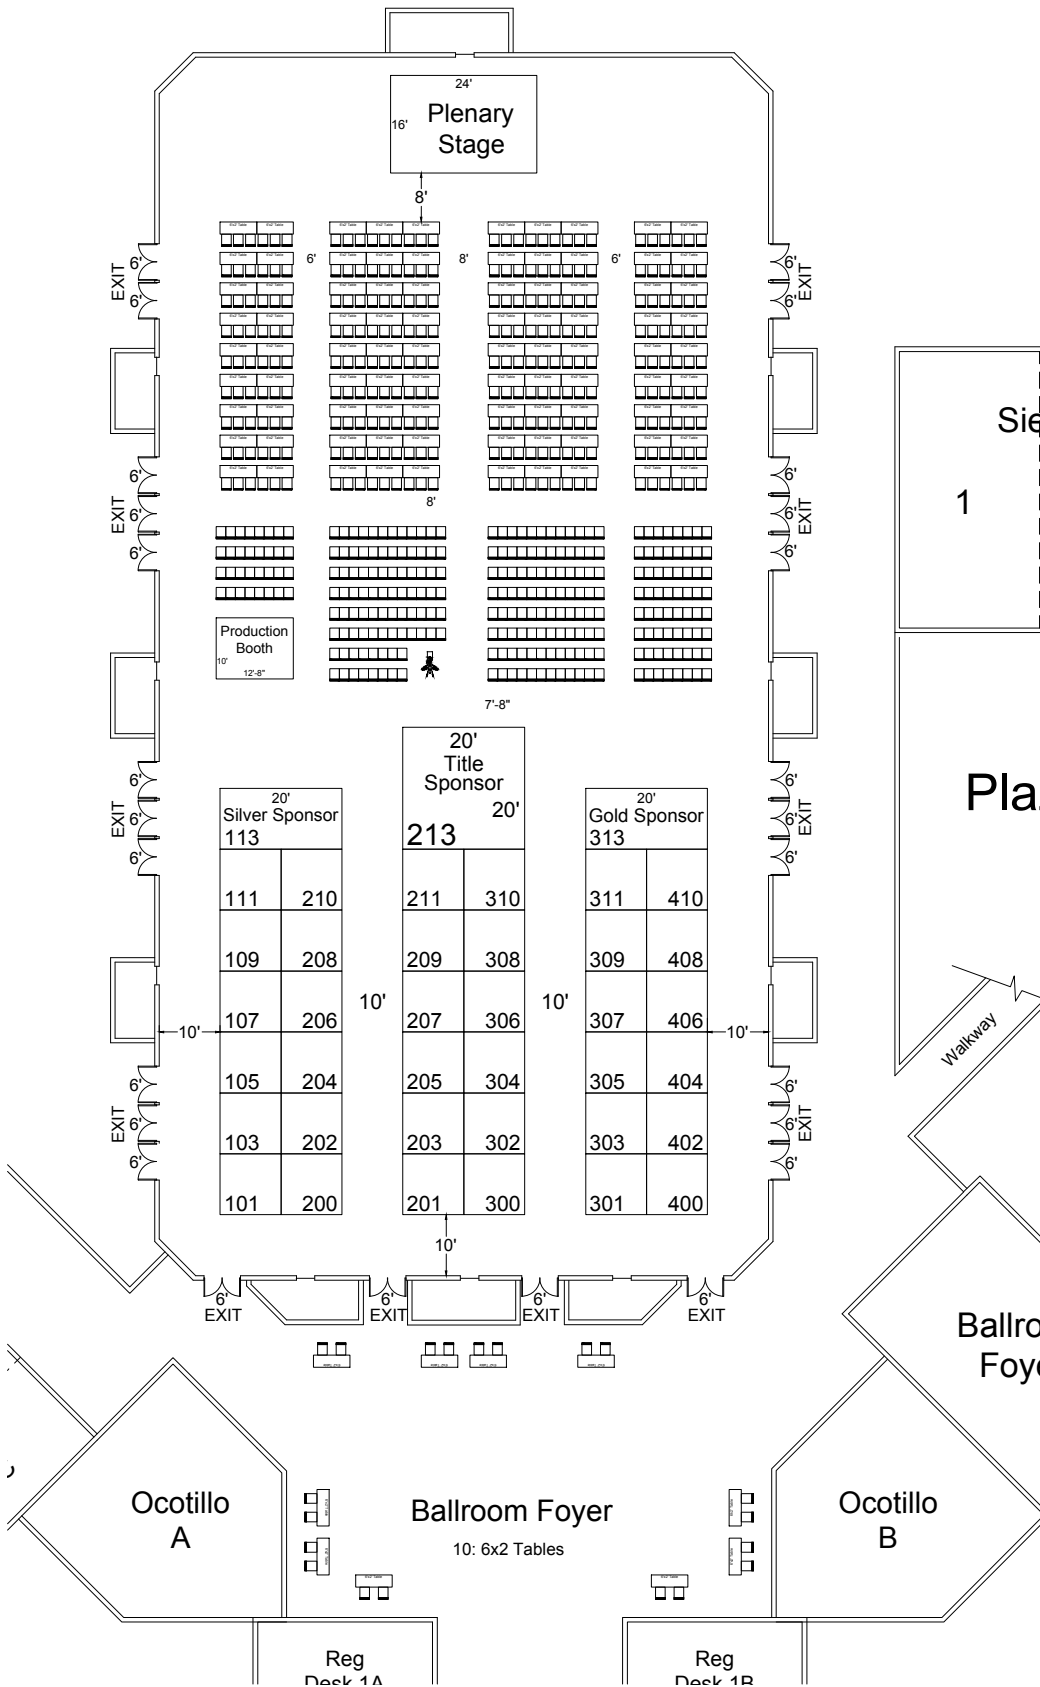

Show Information	
Show Name	Emergency Management Leaders Conference
Show Dates	May 29-30, 2019
Move-In	05/28/19
Job #	P119380519
AE	Kevin Bird

Inventory as of 12/18/2018			
Dimension	Size	Qty	SqFt
10'x10'	100	36	3,600
10'x20'	200	2	400
20'x20'	400	1	400
Totals:		39	4,400

Floor Plan Legend	
FE	Fire Extinguisher
FS	Fire Strobe
FHC	Fire Hose Cabinet

Ballroom Foyer Drawn up from PDF.  
Not to Exact Scale

Venue Info	
Building Name	Arizona Grand Resort and Spa
Hall	Grand Ballroom
Floor	----
Address	8000 S. Arizona Grand Parkway Phoenix, AZ 85044

Drawing Information	
File Path	F:\01 - Floor Plans - 01 - SHEP\EMM\FLOORPLANS\201905_May19Emergency Management Leaders_P119380519.dwg
File Name	Emergency Management Leaders_P119380519.dwg
Drawn By	Jessica Perez
Last Saved	1/21/2019 11:08 AM
Saved By	Jperez
Tab	Floorplan
Paper Size	ANSI full bleed A (11.00 x 8.50 inches)
Scale	NTS

1531 Carroll Drive NW  
Atlanta, GA 30318  
(v) 404-720-8600  
(f) 404-720-8750

Shepard Exposition Services has made every effort to ensure the accuracy of all information contained on this floor plan. However, no warranties, either expressed or implied, are made with respect to this floor plan. Verifying the locations of building columns, utilities, or other architectural components of the facility is the sole responsibility of the exhibitor/show management.

**SUBJECT TO FIRE MARSHAL APPROVAL**